



EQUIPMENT OPTIONAL ACCESSORIES SHOWN ARE DIAGRAMMATIC ONLY AND NOT SITE SPECIFIC

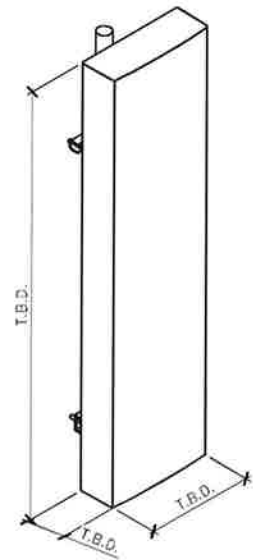

MANUFACTURER: TONGYU
 ANTENNA MODEL: T2008M6R032v03
 HEIGHT: 2080mm
 WIDTH: 499mm
 DEPTH: 198mm
 WEIGHT: 43kg

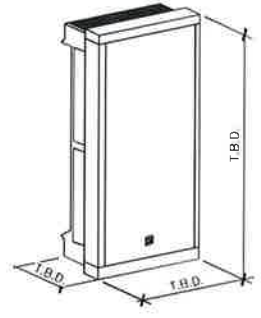


MANUFACTURER: ERICSSON
 ANTENNA MODEL: AIR 6449
 HEIGHT: 841mm
 WIDTH: 522mm
 DEPTH: 211mm
 WEIGHT: 47kg
 WEIGHT WITH MOUNTING KIT: T.B.D.




MODEL: KRE1012395/2 GNSS
 HEIGHT: T.B.D.
 DIA.: T.B.D.

1 ANTENNA ISOMETRICS
 N.T.S.

ROGERS DCI CABINET	
CABINET WEIGHT	499kg (1100lbs)
MAX. CABINET WEIGHT	948kg (2090lbs)

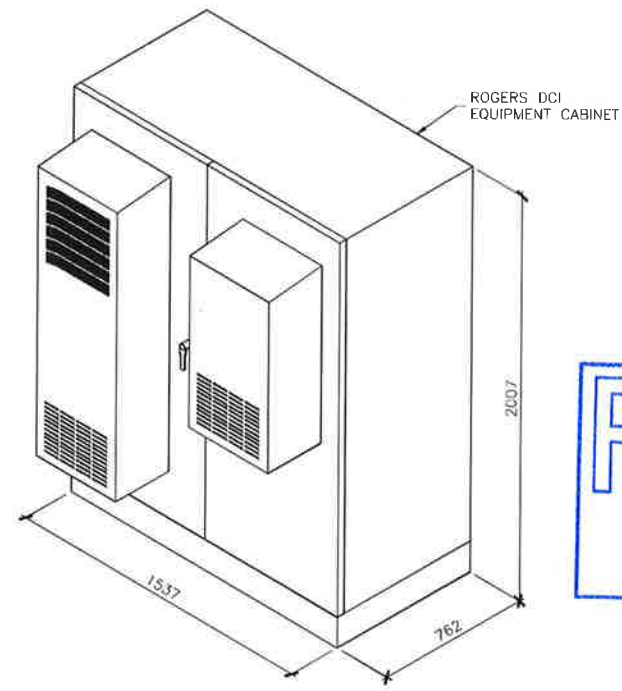

2 ROGERS EQUIPMENT ISOMETRIC
 N.T.S.

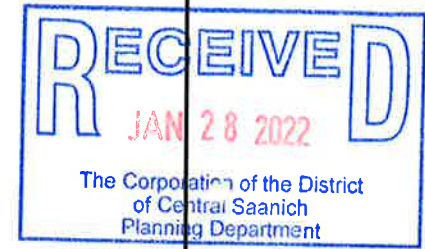

				PROJECT: W4991-2 KEATING CROSS RD 6822 VEYANESS RD CENTRAL SAANICH BRITISH COLUMBIA	SCALE: N/A
					SURREY • CALGARY • MONTREAL TEL: (778) 805-2166 TF: 1+(855) 708-2195 WEB: WWW.COREONECONSULTING.COM CONTACT: INFO@COREONECONSULTING.COM
				DRAWING TITLE: EQUIPMENT AND ANTENNA DETAILS	PROJECT NO: 21C2022
					DRAWING NO: A-1
0	ISSUED FOR REVIEW	AUG 17/21			
REV	DESCRIPTION	DATE	ENGINEERING STAMP		



TRUE NORTH ARROW SHOWN ON THIS DRAWING IS APPROXIMATE ONLY AND MUST BE VERIFIED

NOTES:


1. SITE PLAN INFORMATION OBTAINED FROM THE GOOGLE GIS MAP AND SITE MEASUREMENTS TAKEN BY CORE ONE CONSULTING LTD. DATED JULY 23, 2021. THIS DRAWING DOES NOT REPRESENT A SURVEY.

APPROXIMATE LOCATION OF EXISTING OVERHEAD WIRES


EXISTING STORAGE BUILDING, TYP.

APPROXIMATE LOCATION OF EXISTING PROPERTY LINE, TYP.

ROGERS INSTALLATION. REFER TO A-4 FOR DETAILS

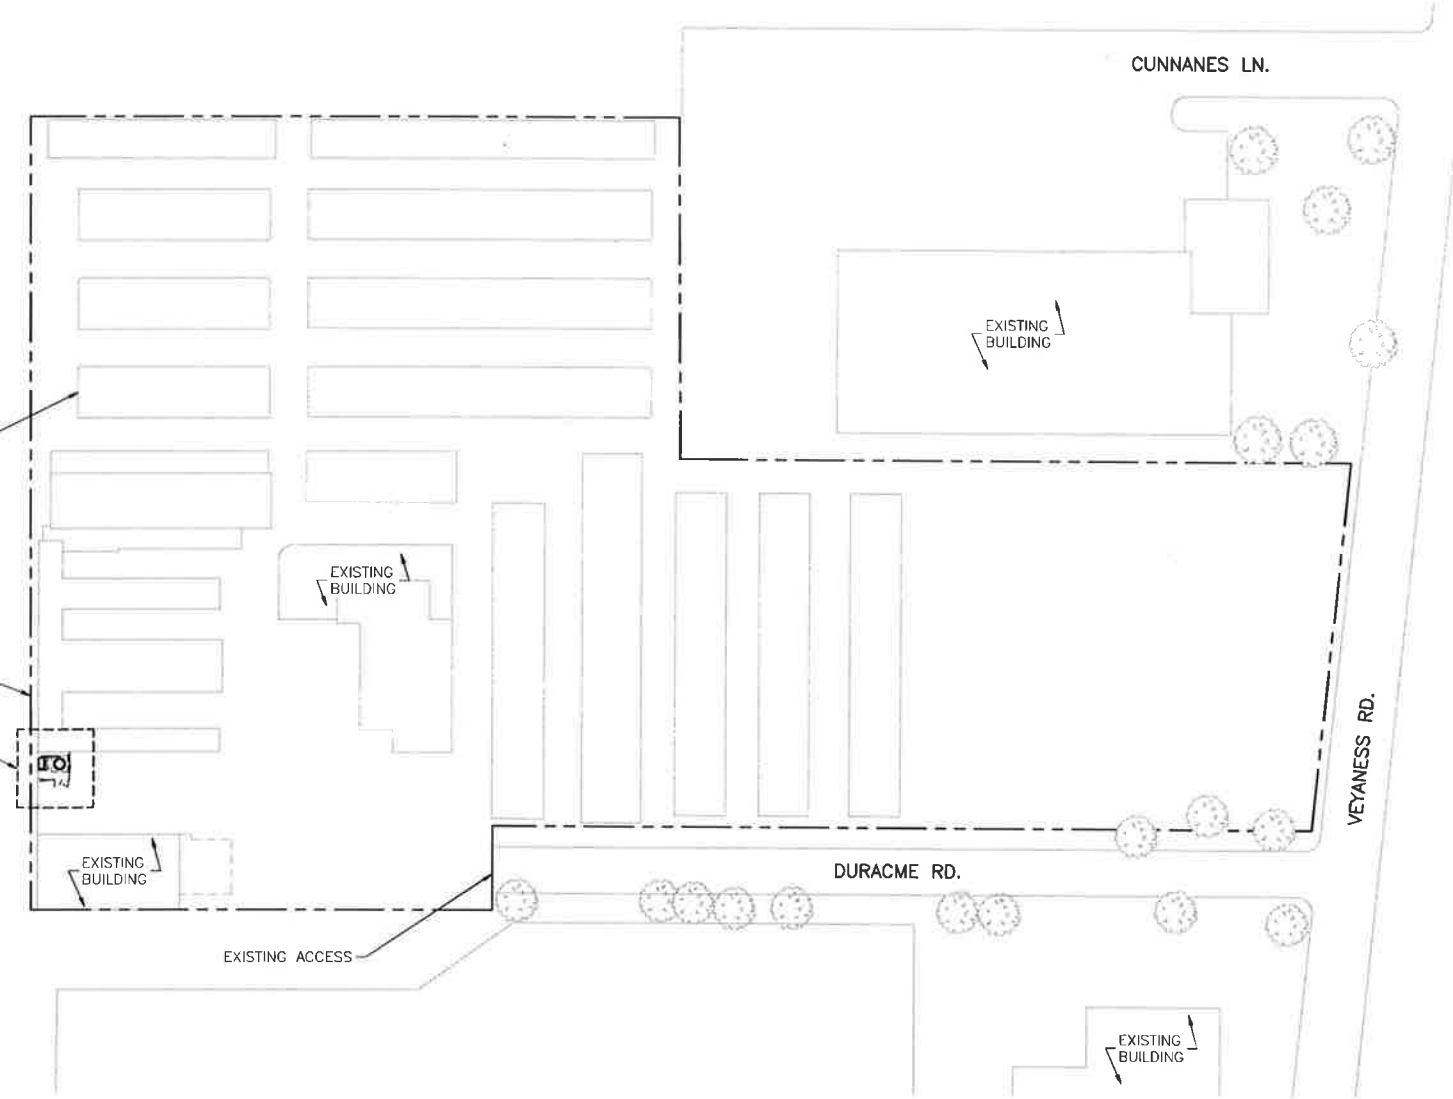

1 SITE PLAN
1:1000

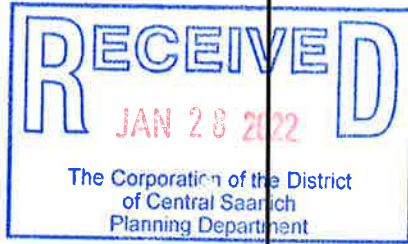


				PROJECT:	W4991-2 KEATING CROSS RD 6822 VEYANESS RD CENTRAL SAANICH BRITISH COLUMBIA	SCALE: AS NOTED
				 SURREY • CALGARY • MONTREAL TEL: (778) 805-2166 TF: 1-(855) 708-2195 WEB: WWW.COREONECONSULTING.COM CONTACT: INFO@COREONECONSULTING.COM	DRAWING TITLE:	SITE PLAN
						DRAWN BY: OI
						DATE: AUG 17/21
						CAD FILE: A-3
						PROJECT NO: 21C2022
						DRAWING NO:
						A-3
0	ISSUED FOR REVIEW	AUG 17/21				
REV	DESCRIPTION	DATE	ENGINEERING STAMP			




TRUE NORTH ARROW SHOWN ON THIS DRAWING IS APPROXIMATE ONLY AND MUST BE VERIFIED

NOTES:

1. ROGERS TO PROVIDE EXACT TOWER MODEL AND SIZE.

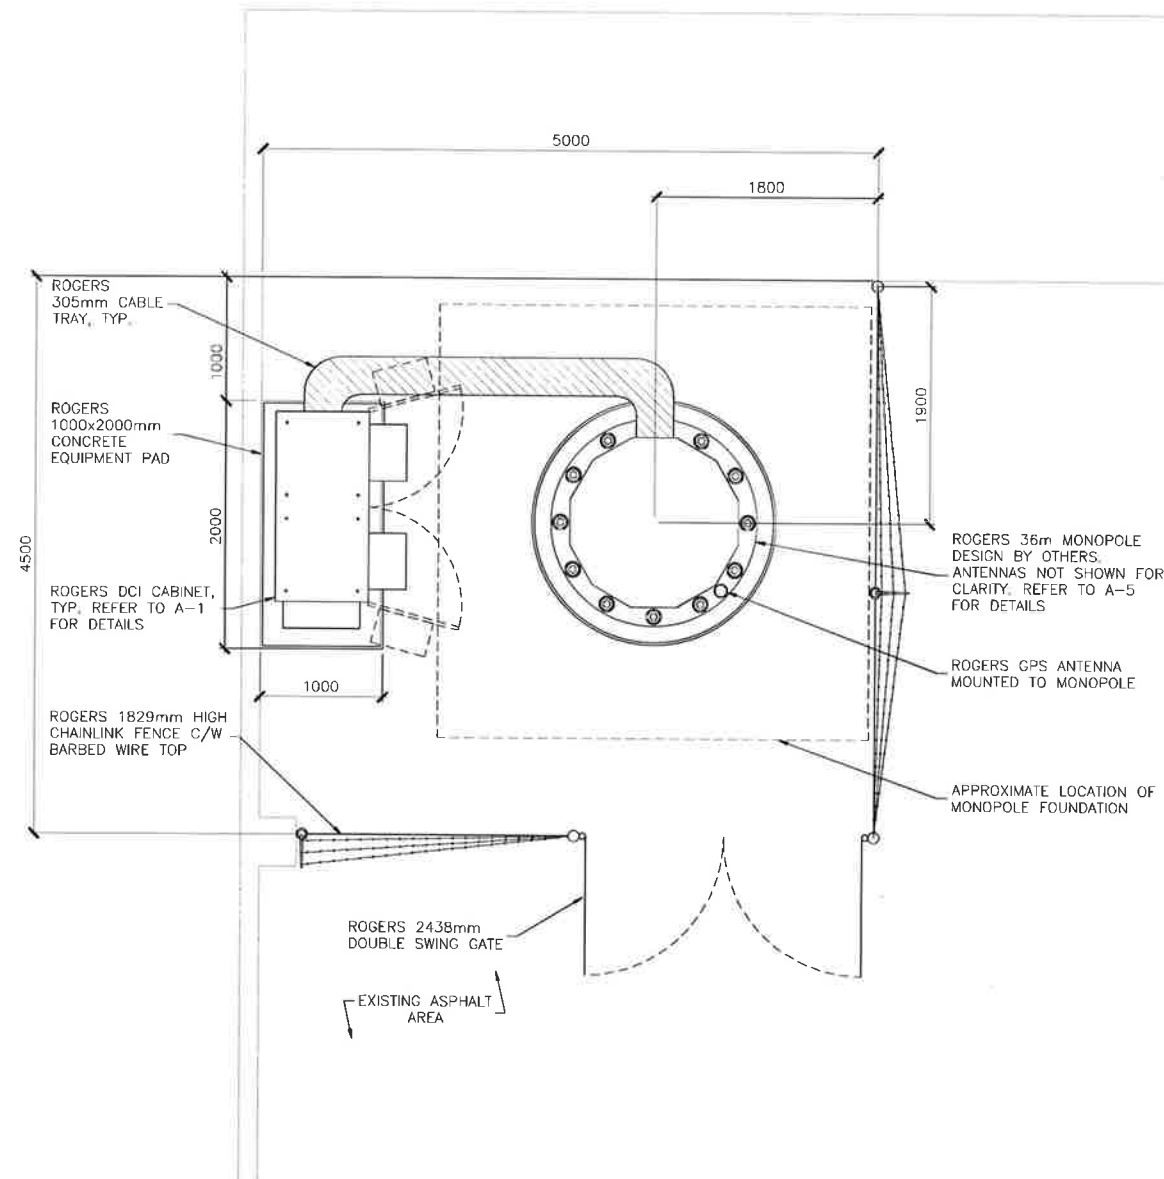

1 COMPOUND LAYOUT
1:50

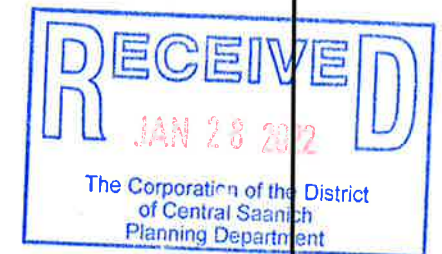

				PROJECT:	W4991-2 KEATING CROSS RD 6822 VEYANESS RD CENTRAL SAANICH BRITISH COLUMBIA	SCALE: AS NOTED
				 SURREY • CALGARY • MONTREAL TEL: (778) 805-2166 TF: 1-(855) 708-2195 WEB: WWW.COREONECONSULTING.COM CONTACT: INFO@COREONECONSULTING.COM	DRAWING TITLE:	COMPOUND LAYOUT
REV	DESCRIPTION	DATE	ENGINEERING STAMP			
D	ISSUED FOR REVIEW	AUG 17/21				DRAWN BY: DI
						DATE: AUG 17/21
						CAD FILE: A-4
						PROJECT NO: 21C2022
						DRAWING NO: A-4





TRUE NORTH ARROW SHOWN ON THIS DRAWING IS APPROXIMATE ONLY AND MUST BE VERIFIED

ANTENNA MOUNTING SHOWN IS DIAGRAMMATIC ONLY AND WILL BE DESIGNED BY TOWER MANUFACTURER

NOTES:

1. ROGERS TO PROVIDE EXACT TOWER MODEL AND SIZE.

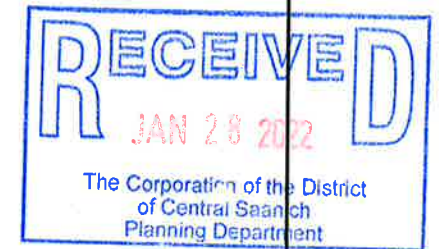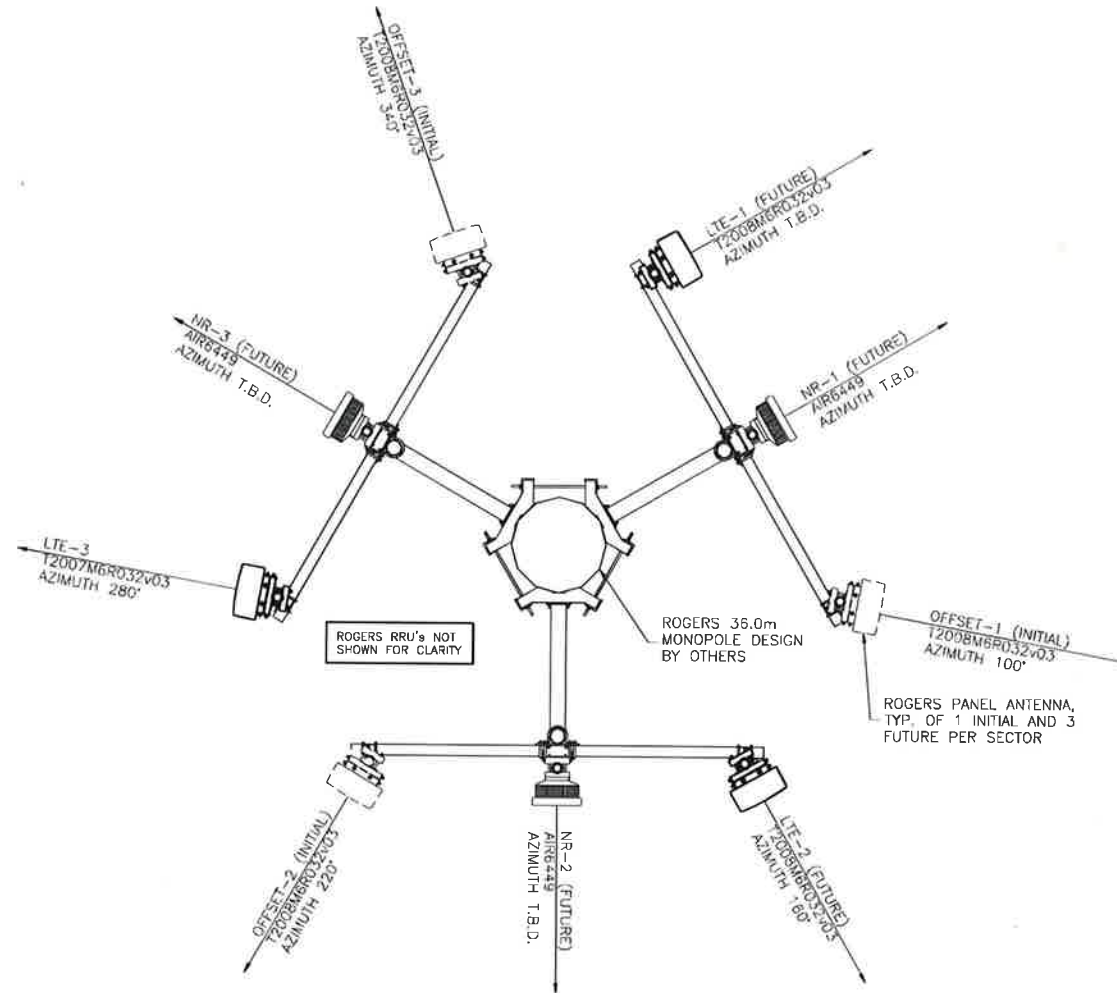

1 ANTENNA LAYOUT
1:50

				PROJECT:	W4991-2 KEATING CROSS RD 6822 VEYANESS RD CENTRAL SAANICH BRITISH COLUMBIA	SCALE: AS NOTED
				<p>SURREY • CALGARY • MONTREAL</p> <p>TEL: (778) 805-2166 TF: 1-(855) 708-2185 WEB: WWW.COREONECONSULTING.COM CONTACT: INFO@COREONECONSULTING.COM</p>	DRAWING TITLE:	ANTENNA LAYOUT
						DRAWN BY: OI
						DATE: AUG 17/21
						CAD FILE: A-5
						PROJECT NO: 21C2022
						DRAWING NO:
						A-5
REV	DESCRIPTION	DATE	ENGINEERING STAMP			
0	ISSUED FOR REVIEW	AUG 17/21				

NOTES:

1. ELEVATION IS DIAGRAMMATIC ONLY.
2. IF REQUIRED, PROVIDE OBSTRUCTION LIGHTING IN ACCORDANCE WITH TRANSPORT CANADA REQUIREMENTS.


T.O. ROGERS MONOPOLE AND PANEL ANTENNAS
±36.0m A.G.L.
ROGERS PANEL ANTENNA RAD CENTRE
35.0m A.G.L.

LIGHTNING ROD
ROGERS PANEL ANTENNA, TYP. OF 1
INITIAL AND 3 FUTURE PER SECTOR
ROGERS RRU, TYP. OF 5
INITIAL AND 5 FUTURE
PER SECTOR


ROGERS 36.0m MONOPOLE
DESIGN BY OTHERS

GRADE
0.0m

1 NORTH ELEVATION
1:200

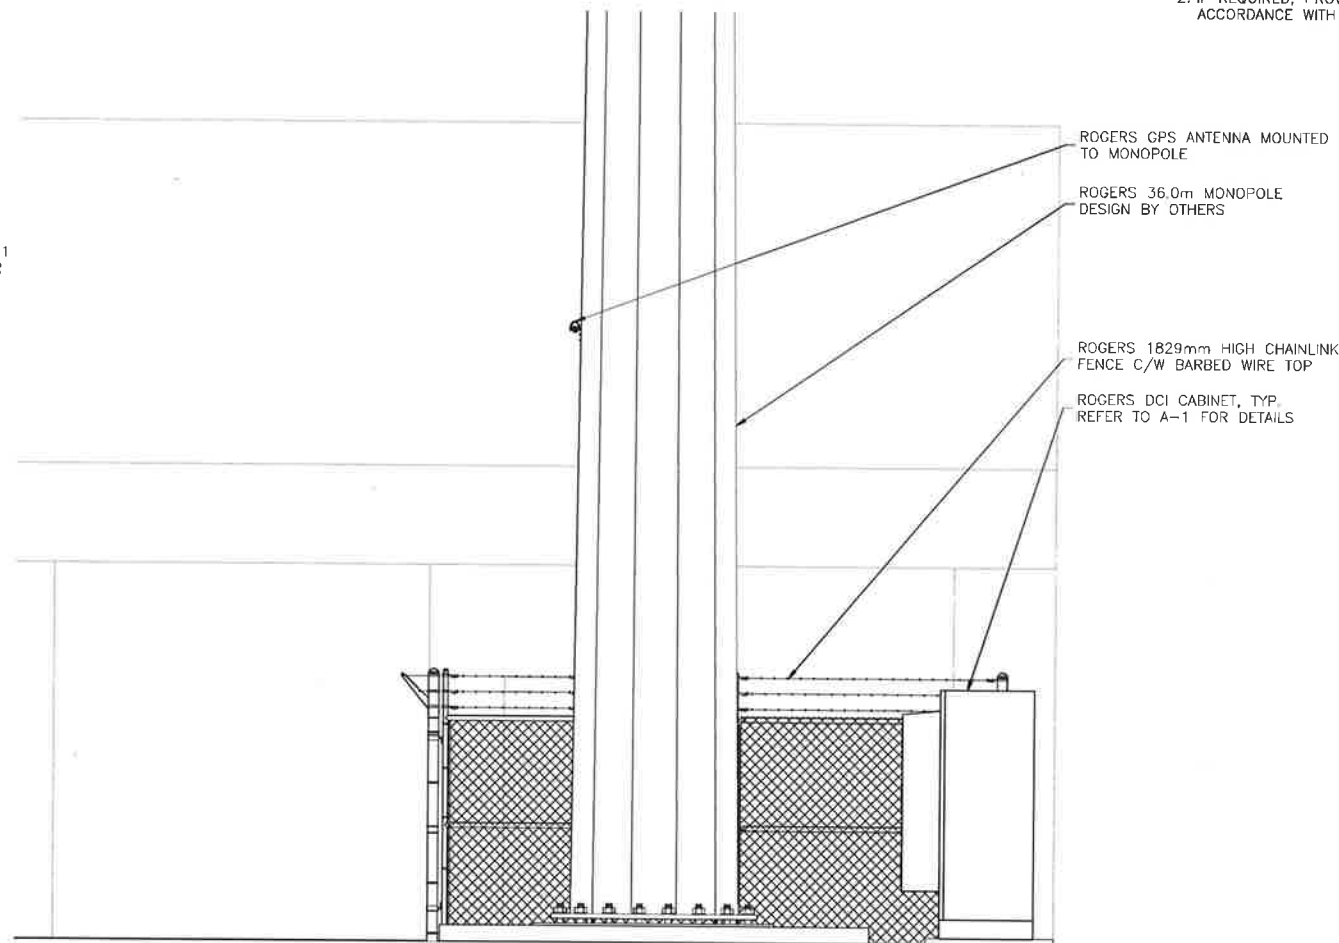



2 PARTIAL NORTH ELEVATION
1:50

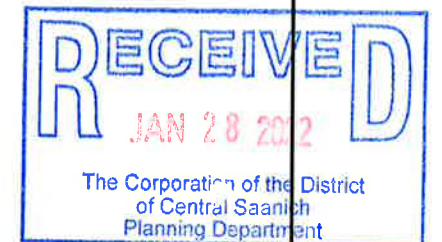

				PROJECT:	W4991-2 KEATING CROSS RD 6822 VEYANESS RD CENTRAL SAANICH BRITISH COLUMBIA	SCALE: AS NOTED
				 SURREY • CALGARY • MONTREAL TEL: (778) 895-2166 TF: 1-855-708-2195 WEB: WWW.COREONECONSULTING.COM CONTACT: INFO@COREONECONSULTING.COM	DRAWING TITLE:	NORTH ELEVATIONS
REV	DESCRIPTION	DATE	ENGINEERING STAMP			
0	ISSUED FOR REVIEW	AUG 17/21				DRAWN BY: OI
						DATE: AUG 17/21
						CAD FILE: A-6
						PROJECT NO: 21C2022
						DRAWING NO: A-6


NOTES:

- 1. ELEVATION IS DIAGRAMMATIC ONLY.
- 2. IF REQUIRED, PROVIDE OBSTRUCTION LIGHTING IN ACCORDANCE WITH TRANSPORT CANADA REQUIREMENTS.

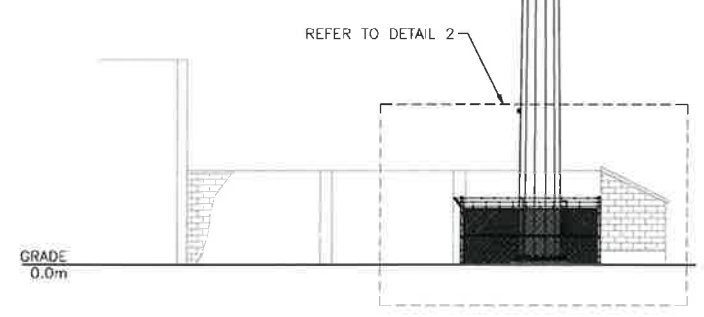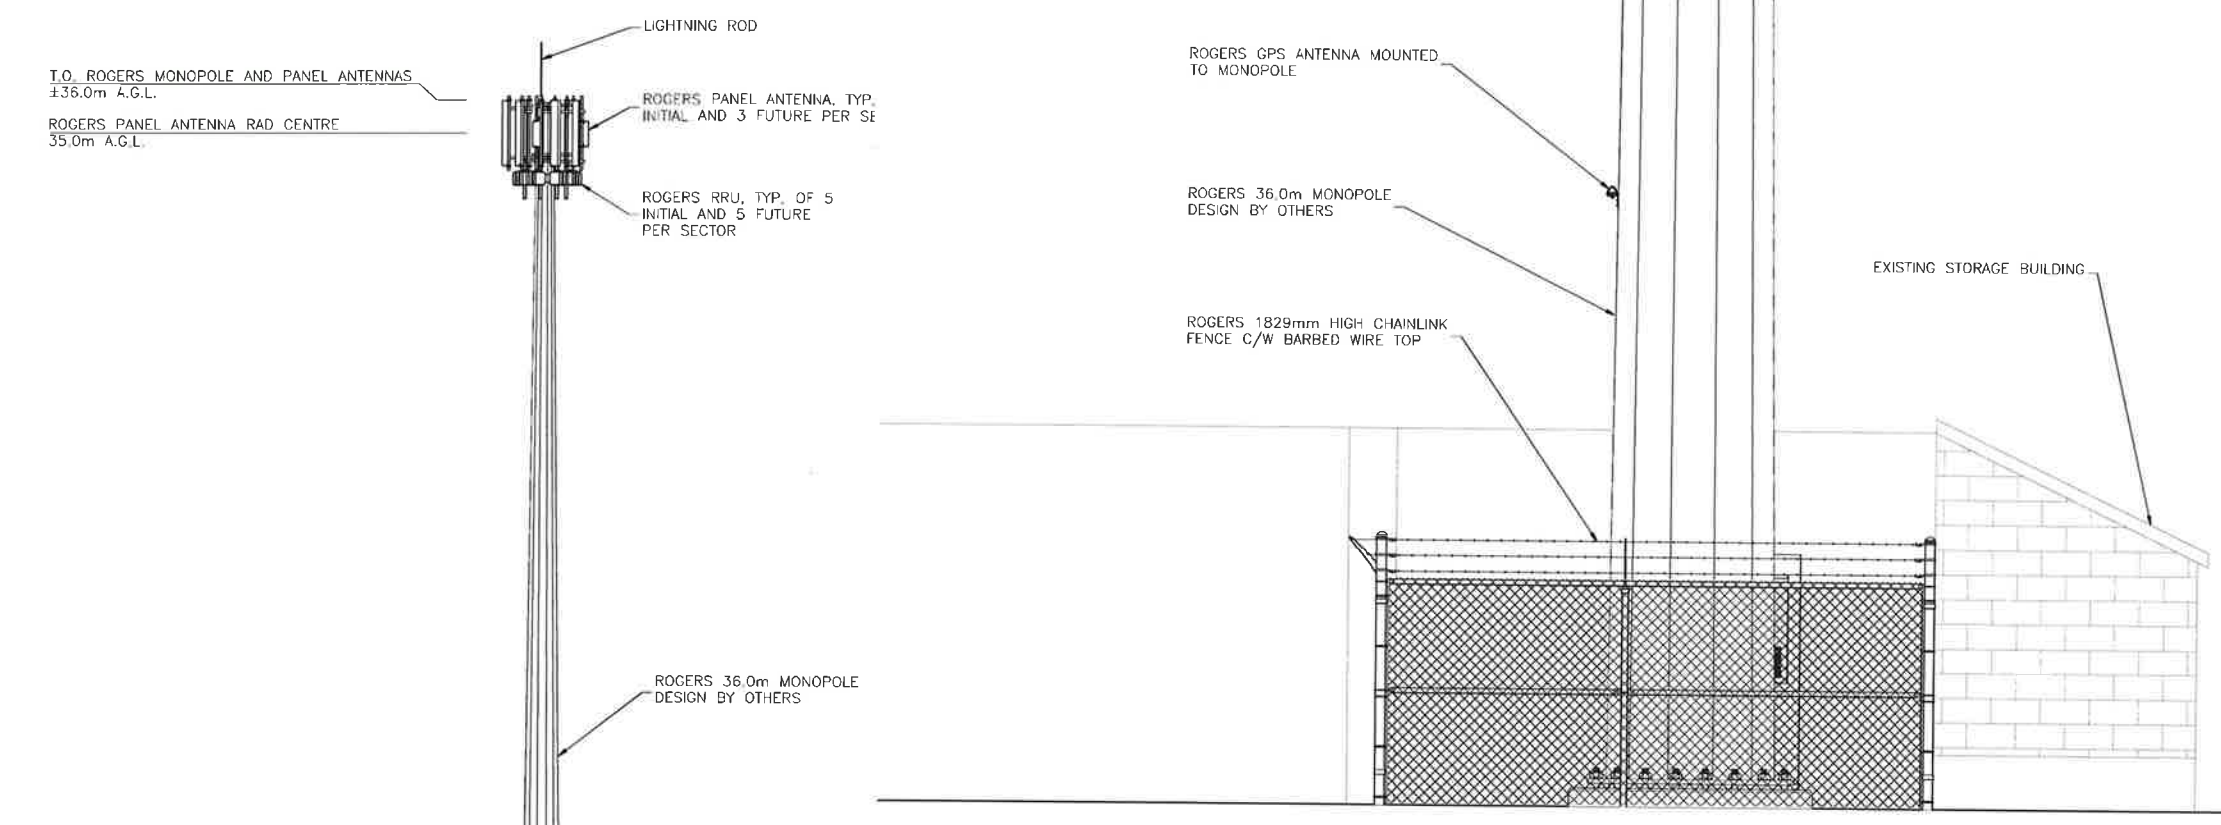

2 PARTIAL EAST ELEVATION
1:50

1 EAST ELEVATION
1:200

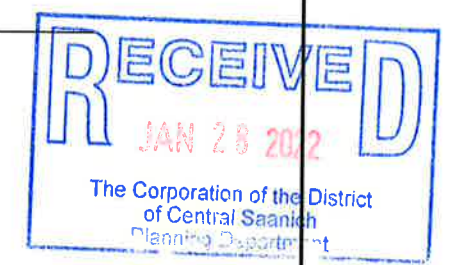

REV	DESCRIPTION	DATE	ENGINEERING STAMP
0	ISSUED FOR REVIEW	AUG 17/21	

SURREY • CALGARY • MONTREAL

TEL: (778) 895-2166
TF: 1-855-708-2195
WEB: WWW.COREONECONSULTING.COM
CONTACT: INFO@COREONECONSULTING.COM

PROJECT:
W4991-2
KEATING CROSS RD
6822 VEYANESS RD

CENTRAL SAANICH
BRITISH COLUMBIA

DRAWING TITLE:
EAST ELEVATIONS


SCALE:	AS NOTED
REVIEWED BY:	LC
APPROVED BY:	DA
DRAWN BY:	OI
DATE:	AUG 17/21
CAD FILE:	A-7
PROJECT NO:	21C2022
DRAWING NO:	A-7

NOTES:

1. ELEVATION IS DIAGRAMMATIC ONLY.
2. IF REQUIRED, PROVIDE OBSTRUCTION LIGHTING IN ACCORDANCE WITH TRANSPORT CANADA REQUIREMENTS.

T.O. ROGERS MONOPOLE AND PANEL ANTENNAS
±36.0m A.G.L.

ROGERS PANEL ANTENNA RAD CENTRE
35.0m A.G.L.

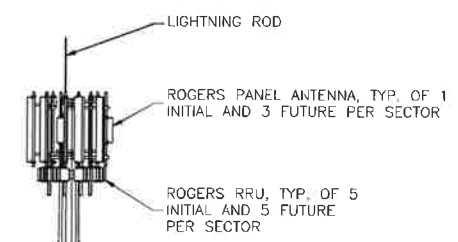


ROGERS 36.0m MONOPOLE
DESIGN BY OTHERS

ROGERS 3658mm DOUBLE
SWING GATE

ROGERS 1829mm HIGH CHAINLINK
FENCE C/W BARBED WIRE TOP

ROGERS DCI CABINET, TYP.
REFER TO A-1 FOR DETAILS


ROGERS GPS ANTENNA MOUNTED
TO MONOPOLE

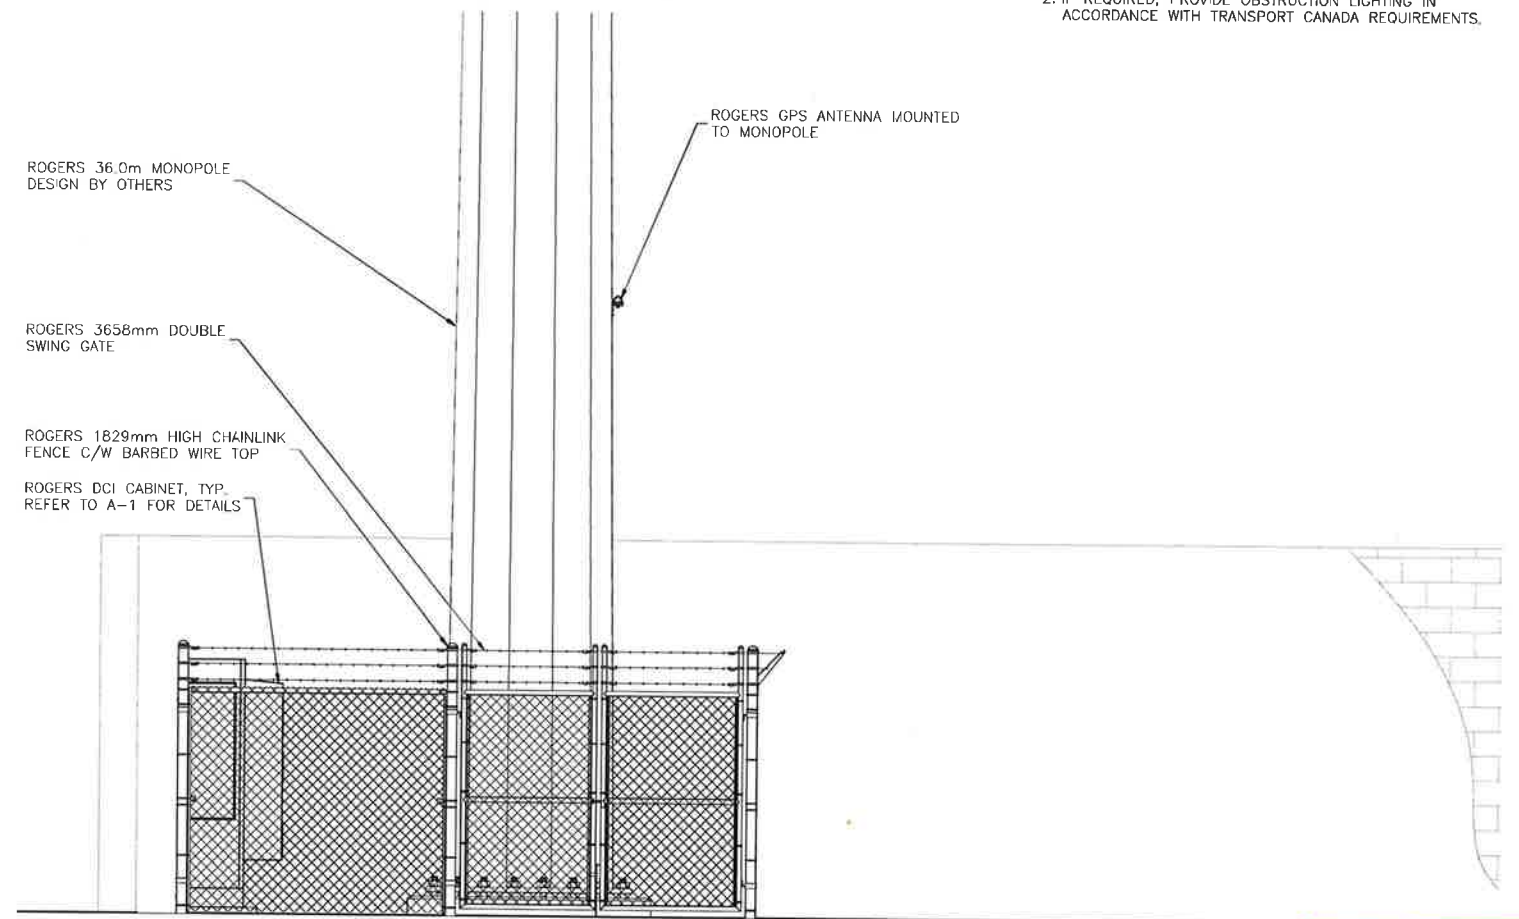

ROGERS 36.0m MONOPOLE
DESIGN BY OTHERS

2 PARTIAL SOUTH ELEVATION
1:50

REFER TO DETAIL 2

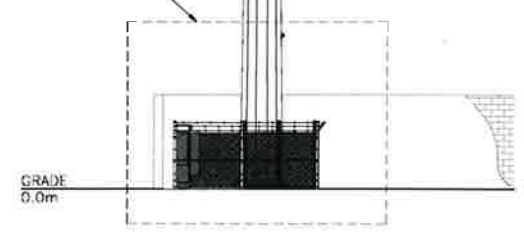

1 SOUTH ELEVATION
1:200

RECEIVED
JAN 28 2022
The Corporation of the District
of Central Saanich
Planning Department

REV	DESCRIPTION	DATE	ENGINEERING STAMP
0	ISSUED FOR REVIEW	AUG 17/21	

ROGERS

CORE ONE
SURREY • CALGARY • MONTREAL

TEL: (778) 805-2166
TF: 1-855-708-2195
WEB: WWW.COREONECONSULTING.COM
CONTACT: INFO@COREONECONSULTING.COM

PROJECT:
W4991-2
KEATING CROSS RD
6822 VEYANESS RD
CENTRAL SAANICH
BRITISH COLUMBIA

DRAWING TITLE:
SOUTH ELEVATIONS

SCALE:	AS NOTED
REVIEWED BY:	LC
APPROVED BY:	DA
DRAWN BY:	OI
DATE:	AUG 17/21
CAD FILE:	A-B
PROJECT NO.:	21C2022
DRAWING NO.:	A-8

NOTES:

1. ELEVATION IS DIAGRAMMATIC ONLY.
2. IF REQUIRED, PROVIDE OBSTRUCTION LIGHTING IN ACCORDANCE WITH TRANSPORT CANADA REQUIREMENTS.

T.O. ROGERS MONOPOLE AND PANEL ANTENNAS
±36.0m A.C.L.
ROGERS PANEL ANTENNA RAD CENTRE
35.0m A.C.L.

LIGHTNING ROD
ROGERS PANEL ANTENNA, TYP. OF
INITIAL AND 3 FUTURE PER SECTOR
ROGERS RRU, TYP. OF 5
INITIAL AND 5 FUTURE
PER SECTOR

ROGERS 36.0m MONOPOLE
DESIGN BY OTHERS



EXISTING STORAGE BUILDING

ROGERS 36.0m MONOPOLE
DESIGN BY OTHERS

ROGERS DCI CABINET, TYP.
REFER TO A-1 FOR DETAILS

ROGERS 1829mm HIGH CHAINLINK
FENCE C/W BARBED WIRE TOP

2 PARTIAL WEST ELEVATION
1:50

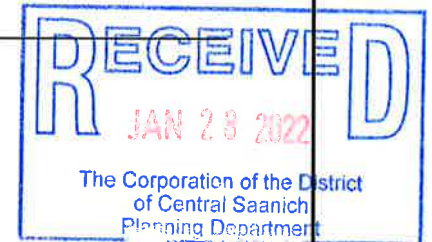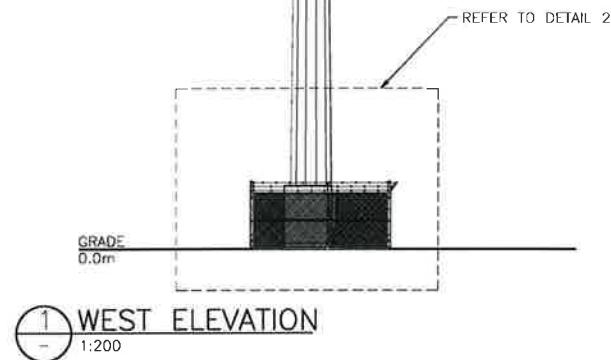

REV	DESCRIPTION	DATE	ENGINEERING STAMP
0	ISSUED FOR REVIEW	AUG 17/21	

ENGINEERING STAMP

ROGERS

CORE ONE
SURREY • CALGARY • MONTREAL

TEL: (778) 805-2166
TF: 1 (855) 768-2195
WEB: WWW.COREONECONSULTING.COM
CONTACT: INFO@COREONECONSULTING.COM

PROJECT:
W4991-2
KEATING CROSS RD
6822 VEYANESS RD
CENTRAL SAANICH
BRITISH COLUMBIA

DRAWING TITLE:
WEST ELEVATIONS

SCALE:	AS NOTED
REVIEWED BY:	LC
APPROVED BY:	DA
DRAWN BY:	OI
DATE:	AUG 17/21
CAD FILE:	A-9
PROJECT NO.:	21C2022
DRAWING NO.:	A-9